



**SITE PLAN**  
**CHARLES JAGO NORTHERN**  
**SPORTS CENTRE**  
**3333 UNIVERSITY WAY**

LEGEND	
	F/D CONNECTION
	FIRE HYDRANT
	NAT. GAS SHUT-OFF
	ELECTRICAL KIOSK
	MAIN ENTRANCE
	ALT. ENTRANCE
	PRE-DESIGNATED ASSEMBLY AREA

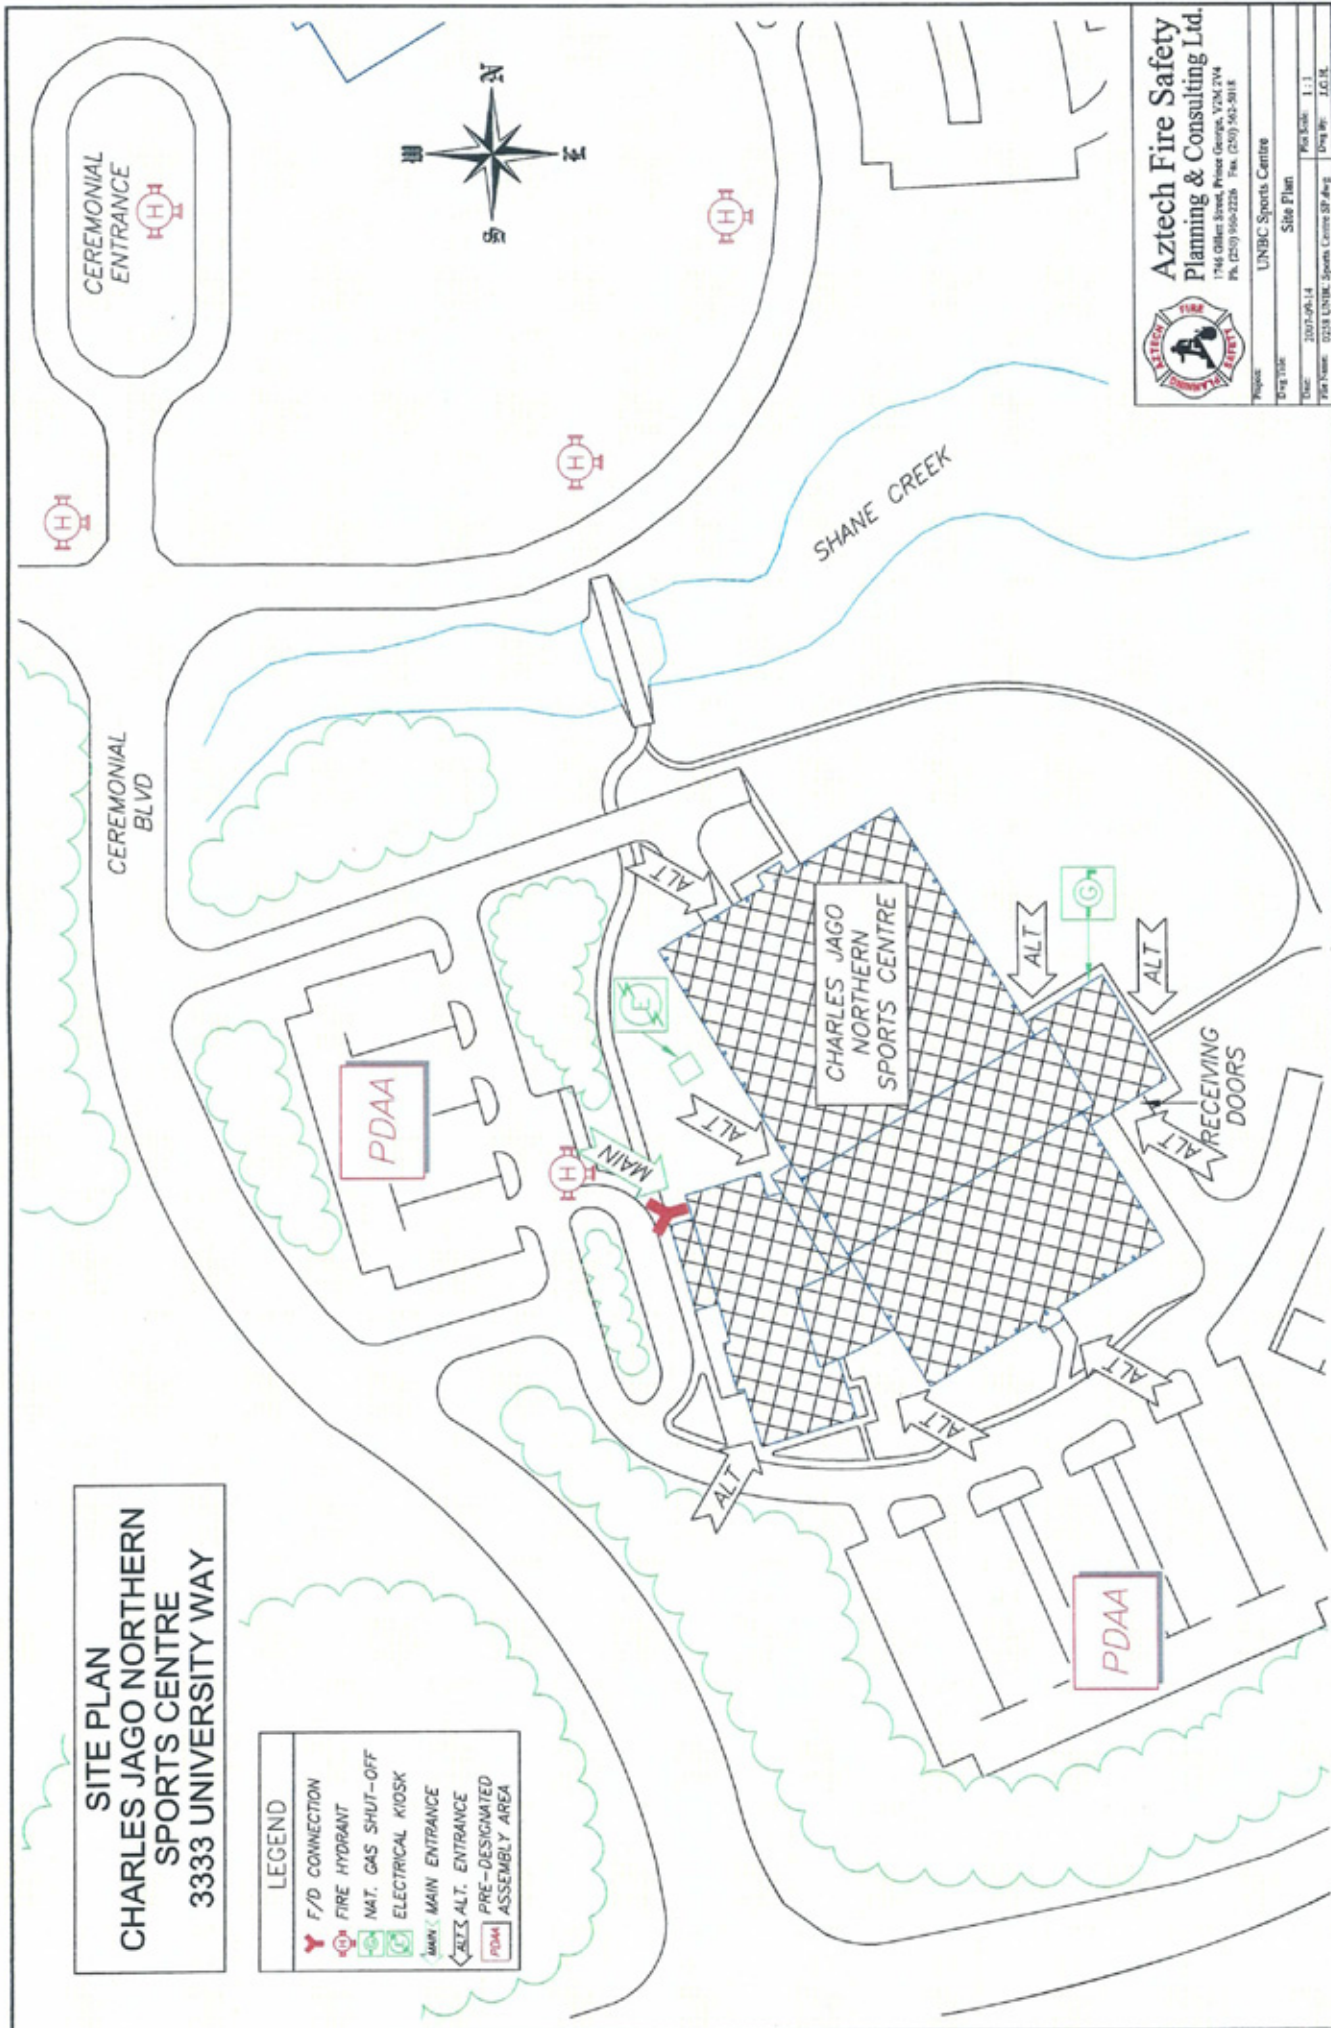


**Aztech Fire Safety Planning & Consulting Ltd.**  
 1744 Gilles Street, Prince George, BC V2M 2W4  
 Ph. (250) 960-2226 Fax. (250) 962-8818

Project:	UNBC Sports Centre
Drawn by:	Site Plan
Date:	2007-09-14
Plot Scale:	1 : 1
Plot Name:	0218 UNBC Sports Centre SP.dwg
Drawn by:	J.C.H.

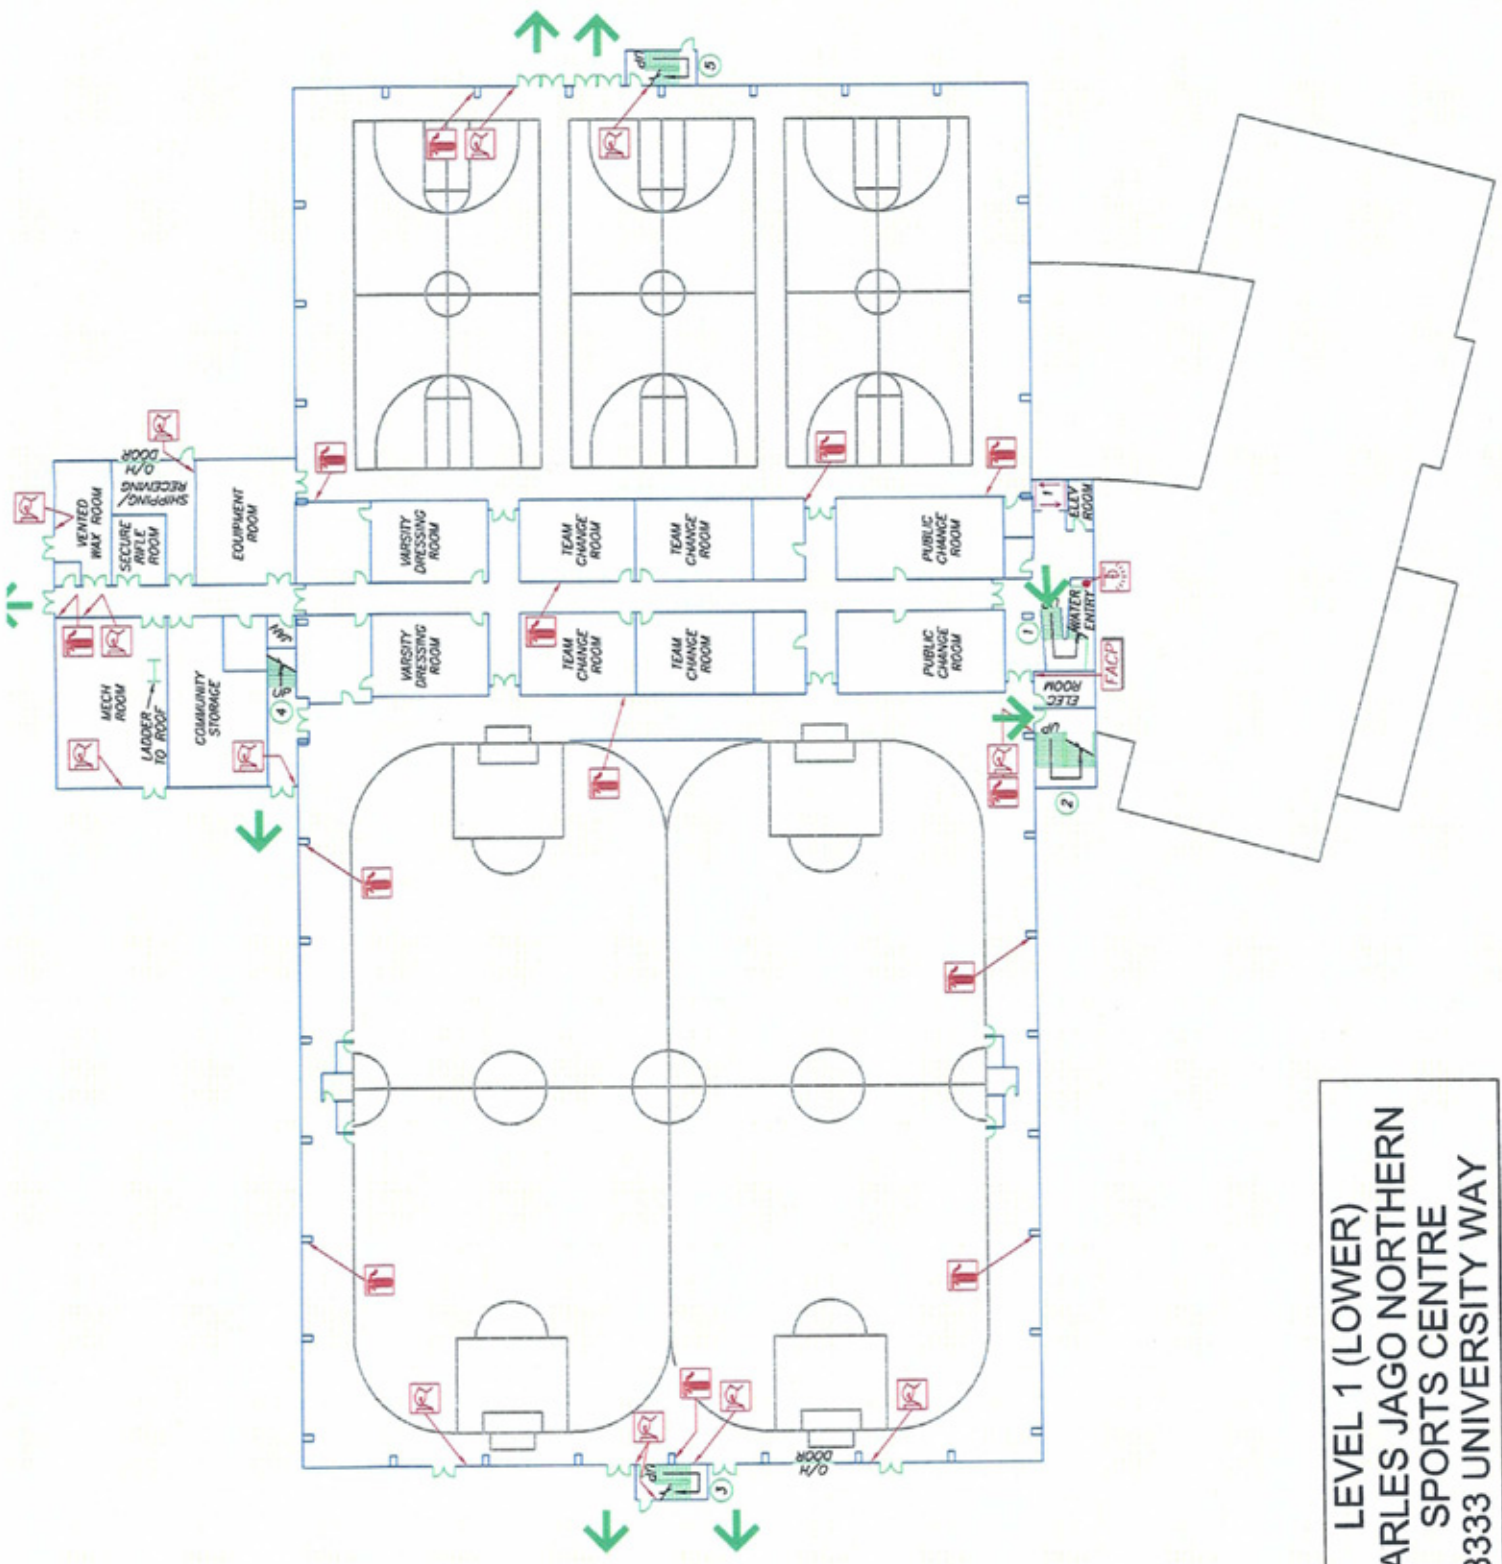

LEVEL 1 (LOWER)  
 CHARLES JAGO NORTHERN  
 SPORTS CENTRE  
 3333 UNIVERSITY WAY

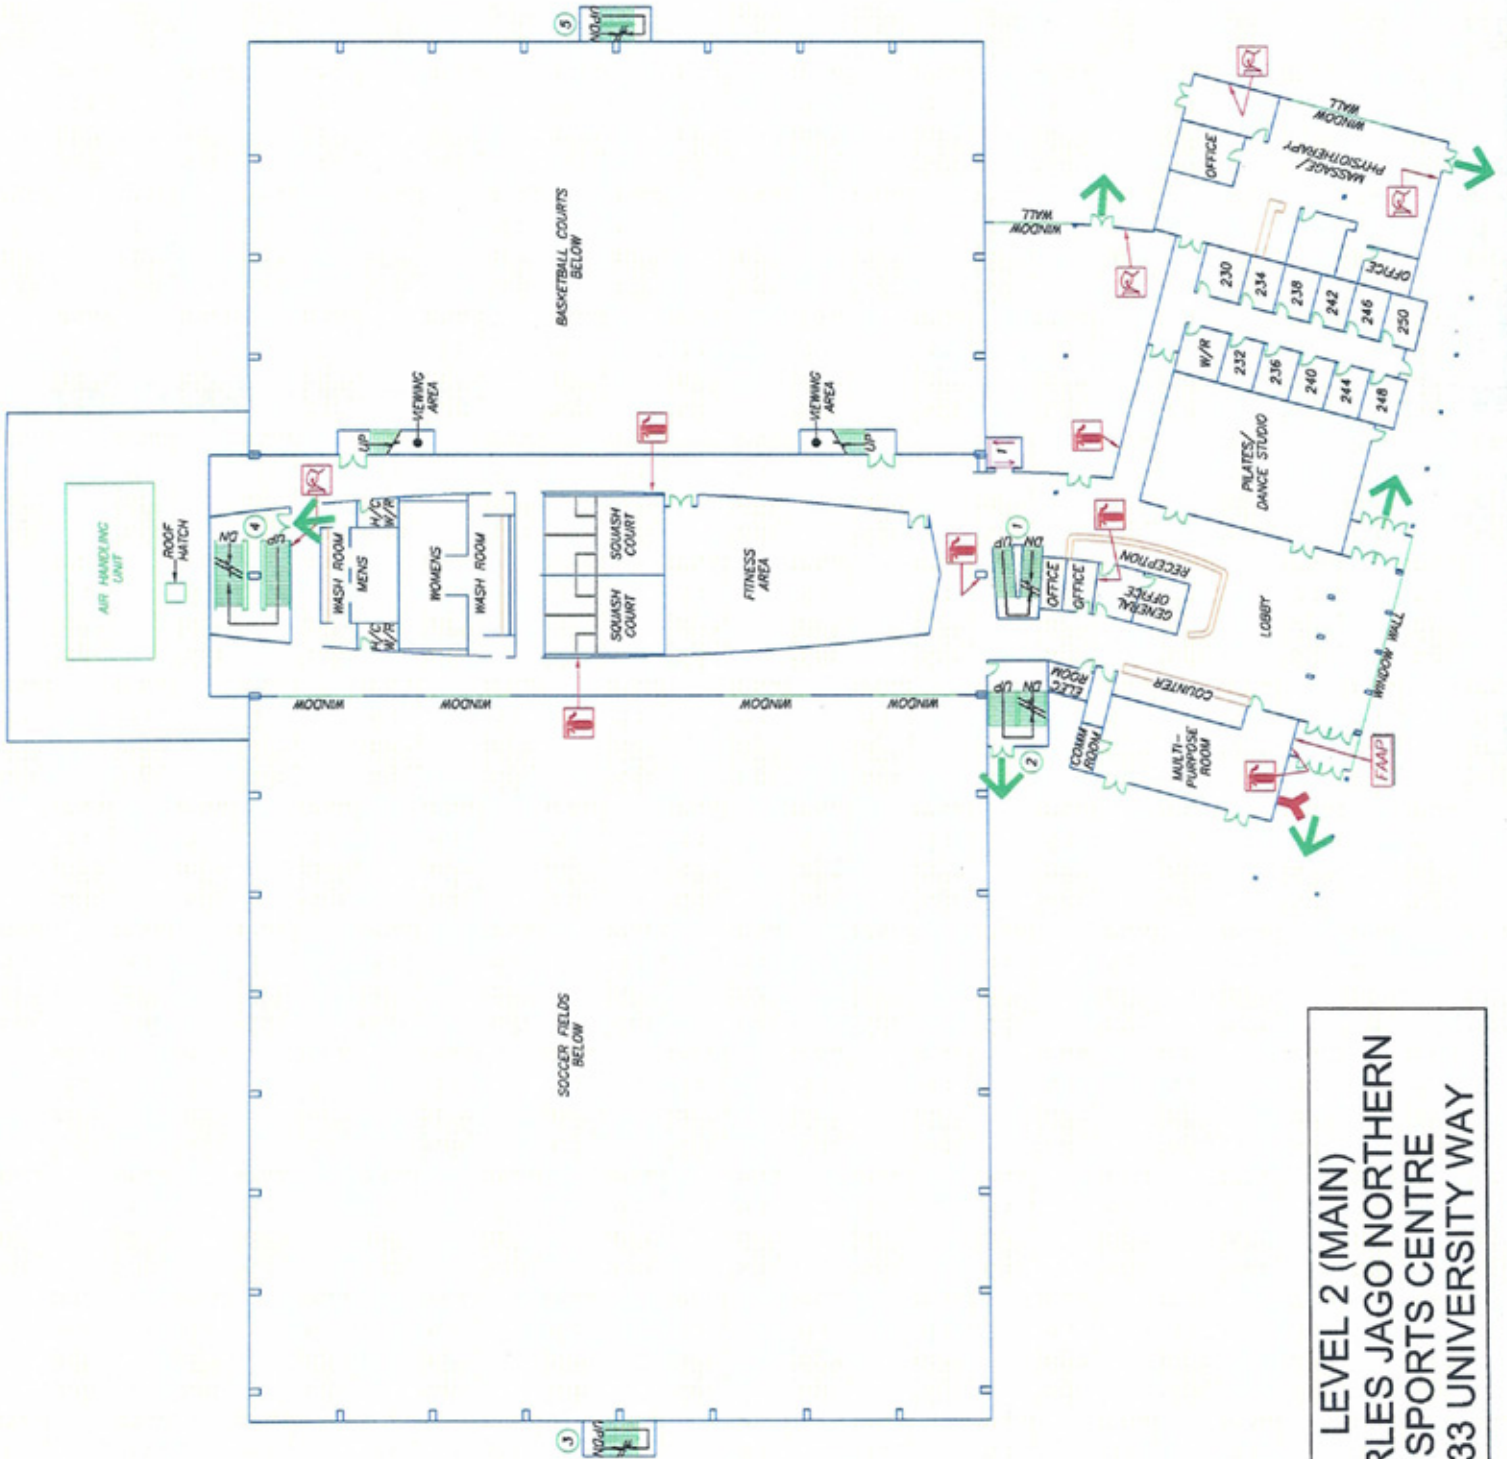

LEVEL 2 (MAIN)  
 CHARLES JAGO NORTHERN  
 SPORTS CENTRE  
 3333 UNIVERSITY WAY